



NORTH ELEVATION
K = 1'-0"



WEST ELEVATION
K = 1'-0"

Renovation of the Residence of:
Mr. & Mrs. Ronald Tauber
80 Saratoga Street
Lido Beach, NY

John Davison Allen, Architect
401 West End Avenue
New York, New York 10024

tel: 212.580.8975 fax: 212.580.0606

No.	Date	Revision

Copyright © 2001
John Davison Allen, Architect

Date: MAY 27, 2002
Scale: 1/4" = 1'-0"
Drawn by: -
Checked by: -

Architectural
Elevations

Sheet No.

A-4
SCHEME G



Renovation of the Residence of
Mr. & Mrs. Ronald Tauber
401 West End Avenue
New York, NY 10024

John Denison Allen, Architect
401 West End Avenue
New York, New York 10024
tel: 212.580.8973 fax: 212.580.6006

No.	Date	Revision

Copyright © 2001
John Denison Allen, Architect
Date: MAY 01, 2002
Scale: 1/4" = 1'-0"
Drawn by: JDA
Checked by: JDA


Architectural
Elevations

A-5
SCHEME G

LIGHT, VENT & EGRESS CALCULATIONS									
ROOM	DIMENSIONS (F.T.)		AREA	REQD. LIGHT	ACTUAL LIGHT	REQD. VENT	ACTUAL VENT	Egress **	Window Type
FIRST FLOOR	Approx	Exact							
GUEST B.R. 1	12	11.2	134.4	13.44	11.20	8.72	10.76	YES	P
GUEST B.R. 2	12	12.25	147	14.7	11.20	7.35	10.76	YES	P
MAID ROOM	7.33	6	82	8.2	17.20	4.6	7.17	YES	U
LIBRARY GUEST	13	13	181	18.1	18.40	9.08	9.20	YES	C1
LIVING RM	29.25	19	555.75	55.575	70.67778	27.7875	80	YES	2B+AA+2N
DINING	14.95	19.5	291.525	29.1525	48.6	14.5/625	80	YES	2N
BREAKFAST RM	13	12	156	15.6	33.4	7.5	33.4	YES	2B,R1

** - Per Andersen Catalogue, windows which are noted "YES" in the "Meets Egress" column have clear operable area of 5.7 sq. ft. and min operable dimension of 20" dr. Width & 24" dr. Height.

SEE SECOND FLOOR PLAN FOR WINDOW SCHEDULE

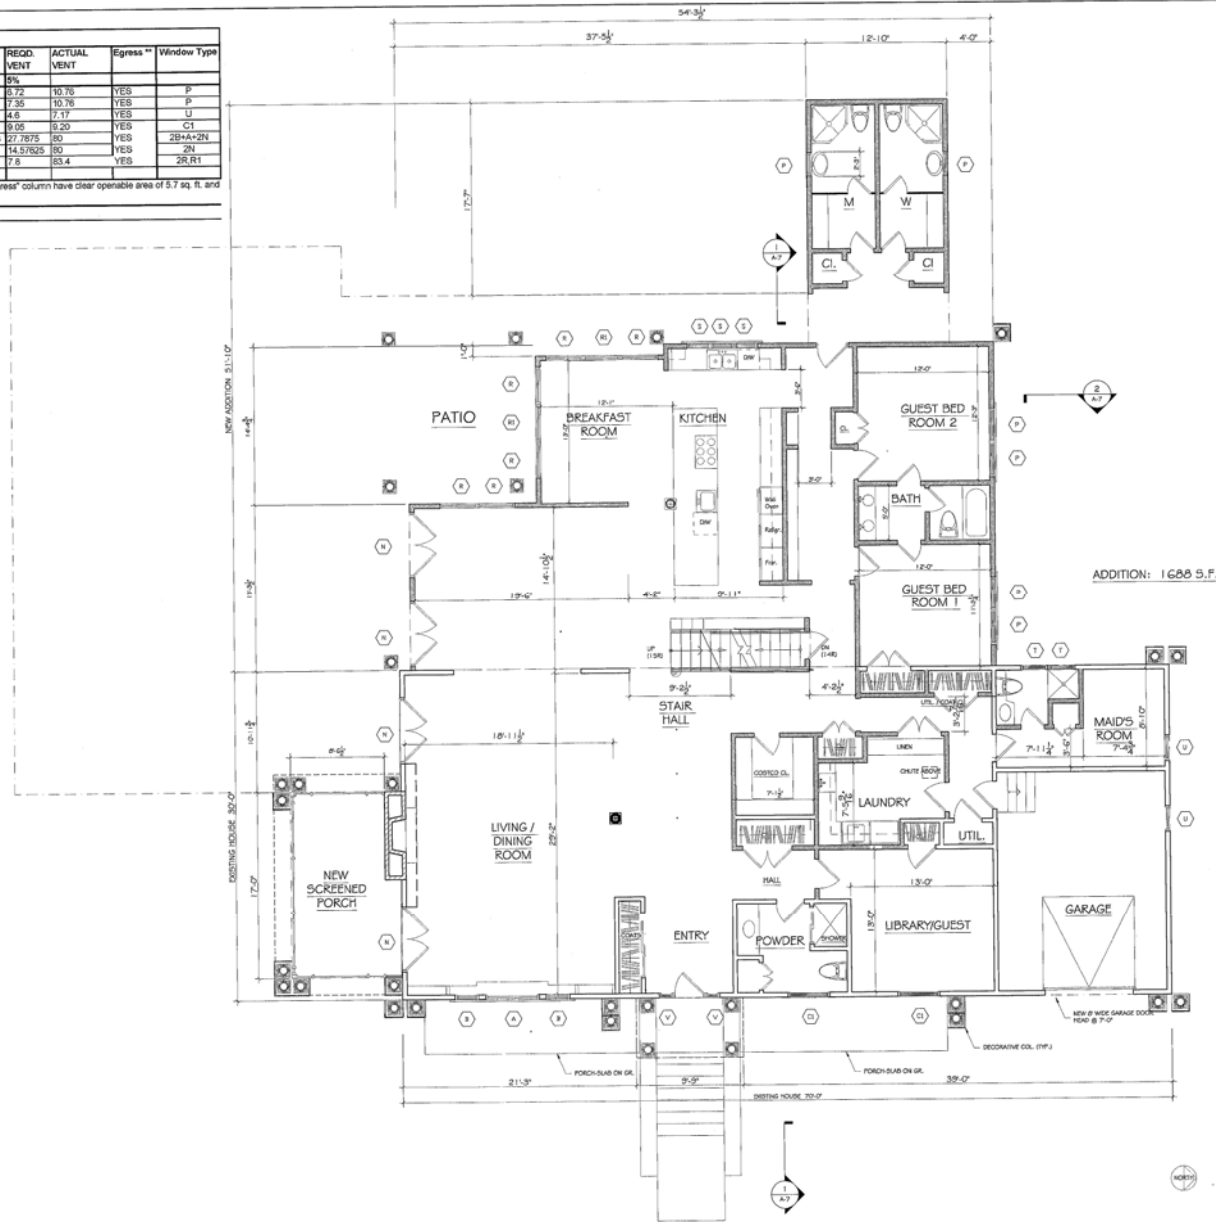

Renovation of the Residence of:
Mr. & Mrs. Ronald Tauber
80 Saratoga Street
Lido Beach, NY

John Devine Allen, Architect
401 West End Avenue
New York, New York 10024

tel 212 580 8979 fax 212 580 6056

No. Date Revision

No.	Date	Revision
1	5/20/02	REVISED PER
2	5/20/02	REVISED PER

Copyright © 2001
John Devine Allen, Architect

Date: MAY 27, 2002

Scale: 1/8" = 1'-0"

Drawn by: JDA

Checked by: JDA

Title: ARCHITECTURAL


FIRST FLOOR PLAN

Sheet No.

A-2

SCHEME G

Windows Schedule									
	Activity	Start	End	Day	Day(s)	Time(s)	Team	Hours	Project #
A	APP-421025-PC-FILE	1	15	Mon	Mon	10:00	10:00	10.00	10.00
B	APP-421025-PC-FILE	1	15	Mon	Mon	10:00	10:00	10.00	10.00
C	APP-421025-PC-FILE	1	15	Mon	Mon	10:00	10:00	10.00	10.00
D	APP-421025-PC-FILE	1	15	Mon	Mon	10:00	10:00	10.00	10.00
E	APP-421025-PC-FILE	1	15	Mon	Mon	10:00	10:00	10.00	10.00
F	APP-421025-PC-FILE	1	15	Mon	Mon	10:00	10:00	10.00	10.00
G	APP-421025-PC-FILE	1	15	Mon	Mon	10:00	10:00	10.00	10.00
H	APP-421025-PC-FILE	1	15	Mon	Mon	10:00	10:00	10.00	10.00
I	APP-421025-PC-FILE	1	15	Mon	Mon	10:00	10:00	10.00	10.00
J	APP-421025-PC-FILE	1	15	Mon	Mon	10:00	10:00	10.00	10.00
K	APP-421025-PC-FILE	1	15	Mon	Mon	10:00	10:00	10.00	10.00
L	APP-421025-PC-FILE	1	15	Mon	Mon	10:00	10:00	10.00	10.00
M	APP-421025-PC-FILE	1	15	Mon	Mon	10:00	10:00	10.00	10.00
N	APP-421025-PC-FILE	1	15	Mon	Mon	10:00	10:00	10.00	10.00
O	APP-421025-PC-FILE	1	15	Mon	Mon	10:00	10:00	10.00	10.00
P	APP-421025-PC-FILE	1	15	Mon	Mon	10:00	10:00	10.00	10.00
Q	APP-421025-PC-FILE	1	15	Mon	Mon	10:00	10:00	10.00	10.00
R	APP-421025-PC-FILE	1	15	Mon	Mon	10:00	10:00	10.00	10.00
S	APP-421025-PC-FILE	1	15	Mon	Mon	10:00	10:00	10.00	10.00
T	APP-421025-PC-FILE	1	15	Mon	Mon	10:00	10:00	10.00	10.00
U	APP-421025-PC-FILE	1	15	Mon	Mon	10:00	10:00	10.00	10.00
V	APP-421025-PC-FILE	1	15	Mon	Mon	10:00	10:00	10.00	10.00
W	APP-421025-PC-FILE	1	15	Mon	Mon	10:00	10:00	10.00	10.00
X	APP-421025-PC-FILE	1	15	Mon	Mon	10:00	10:00	10.00	10.00
Y	APP-421025-PC-FILE	1	15	Mon	Mon	10:00	10:00	10.00	10.00
Z	APP-421025-PC-FILE	1	15	Mon	Mon	10:00	10:00	10.00	10.00
AA	APP-421025-PC-FILE	1	15	Mon	Mon	10:00	10:00	10.00	10.00
AB	APP-421025-PC-FILE	1	15	Mon	Mon	10:00	10:00	10.00	10.00
AC	APP-421025-PC-FILE	1	15	Mon	Mon	10:00	10:00	10.00	10.00
AD	APP-421025-PC-FILE	1	15	Mon	Mon	10:00	10:00	10.00	10.00
AE	APP-421025-PC-FILE	1	15	Mon	Mon	10:00	10:00	10.00	10.00
AF	APP-421025-PC-FILE	1	15	Mon	Mon	10:00	10:00	10.00	10.00
AG	APP-421025-PC-FILE	1	15	Mon	Mon	10:00	10:00	10.00	10.00
AH	APP-421025-PC-FILE	1	15	Mon	Mon	10:00	10:00	10.00	10.00
AI	APP-421025-PC-FILE	1	15	Mon	Mon	10:00	10:00	10.00	10.00
AJ	APP-421025-PC-FILE	1	15	Mon	Mon	10:00	10:00	10.00	10.00
AK	APP-421025-PC-FILE	1	15	Mon	Mon	10:00	10:00	10.00	10.00
AL	APP-421025-PC-FILE	1	15	Mon	Mon	10:00	10:00	10.00	10.00
AM	APP-421025-PC-FILE	1	15	Mon	Mon	10:00	10:00	10.00	10.00
AN	APP-421025-PC-FILE	1	15	Mon	Mon	10:00	10:00	10.00	10.00
AO	APP-421025-PC-FILE	1	15	Mon	Mon	10:00	10:00	10.00	10.00
AP	APP-421025-PC-FILE	1	15	Mon	Mon	10:00	10:00	10.00	10.00
AP	APP-421025-PC-FILE	1	15	Mon	Mon	10:00	10:00	10.00	10.00
AP	APP-421025-PC-FILE	1	15	Mon	Mon	10:00	10:00	10.00</	

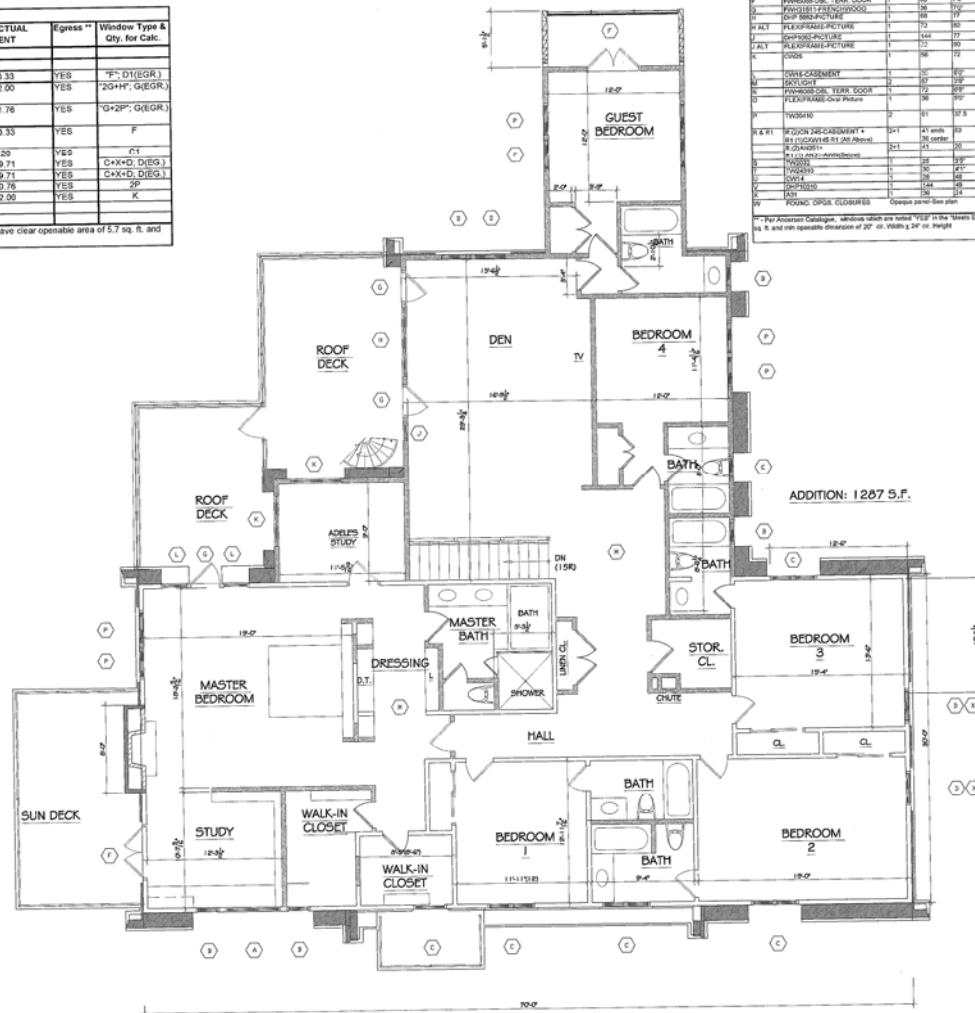

Renovation of the Residence of:
Mr. & Mrs. Ronald Tauber
80 Saratoga Street
Lido Beach, NY

John Derisave Allen, Architect
601 West End Avenue
New York, New York 10024

tel: 212-580-8975 fax: 212-580-0006

No.	Date	Revision
2	8/20/02	GEN. REVISIONS PLUMBING


Copyright © 2001
John Derisave Allen, Architect

Date: MAY 27, 2001
Scale: 1/4" = 1'-0"
Drawn by: -
Checked by: -


Title
ARCHITECTURAL
SECOND FLOOR PLAN

Sheet No.

A-3
SCHEME E

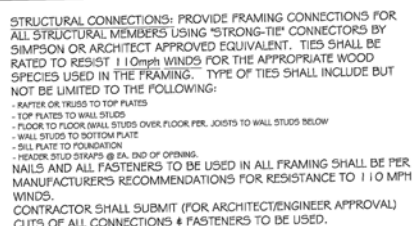40

A-6

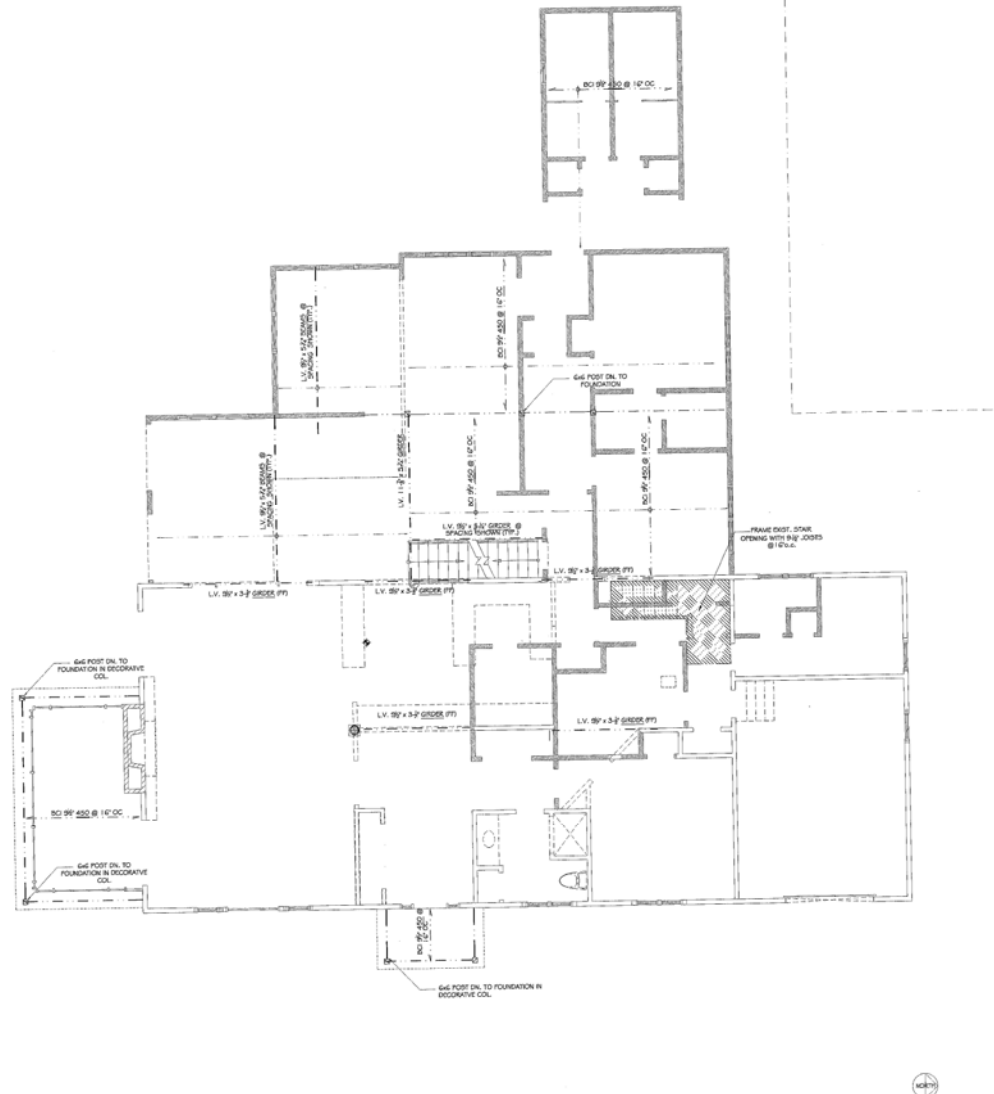

Renovation of the Residence of
Mr. & Mrs. Ronald Tauber
 80 Saratoga Street
 Lake Beach, NY

John Devlin Allen, Architect
 401 West End Avenue
 New York, New York 10024

tel: 212-580-8975 fax: 212-580-0606

No.	Date	Revision


2002 Note

Copyright © 2001
 John Devlin Allen, Architect


Date: MAY 01, 2002
 Scale: 1/8" = 1'-0"
 Drawn by: z
 Checked by: -

Title
2nd FLOOR FRAMING
FIRST FLOOR PLAN

Sheet No.
S-2
 SCHEME G

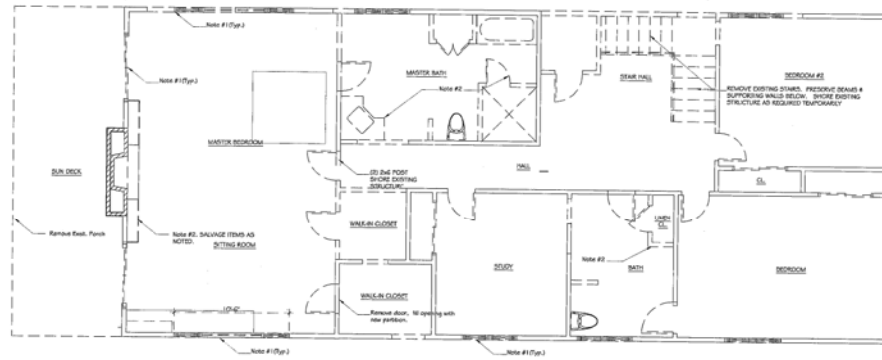

Second Floor

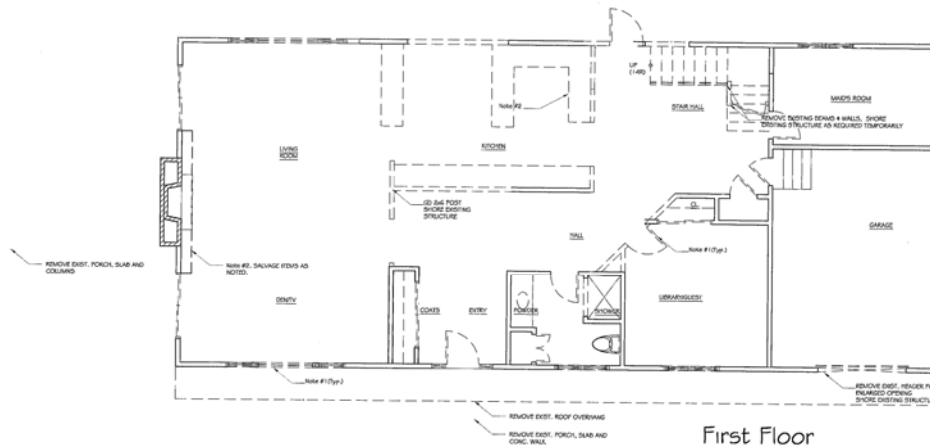

First Floor

NOTES:
General:
- Verify sizes and/or dimensions noted during demolition and notify Architect of discrepancies.
- Remove all exterior windows and doors unless otherwise noted. Where indicated.
Note 1: Remove walls, doors, windows shown dashed (Typ.)
Note 2: Remove interior built-in elements, including but not limited to counters, cabinets.
Note 3: Preserve existing beams & walls, shore existing structure as required.

Removal of the Residence of:
Mr. & Mrs. Ronald Tauber
80 Saratoga Street
Lake Ronkonkago, NY

John Devine Allen, Architect
601 West End Avenue
New York, New York 10024

tel: 212.580.8975 fax: 212.580.8606

No.	Date	Revision

Copyright © 2001
John Devine Allen, Architect


Date: MAY 01, 2002
Scale: 1/8" = 1'-0"
Drawn by: JDA
Checked by: JDA

Title:
**DEMOLITION
FIRST FLOOR PLAN
SECOND FLOOR PLAN**

Sheet No.

D-2
SCHEME G

LIGHTING FIXTURE SCHEDULE:				
MARK	TYPE	MANUFACTURER	CATALOG NO	LAMP
A	LOW VOLTAGE UP LIGHT	HALO	H14991 142ING GOLD ALZAR 4" OPENING	50W MR-16
B	LOW VOLTAGE DOWN LIGHT	HALO	TO BE SELECTED BY ARCH.	50W MR-16
C	WALL MTD FIXTURE TO BE FURNISHED BY OWNER AND INSTALLED BY CONTRACTOR			100W A-21
D	UNDER-CABINET LIGHTING SUPPLIED BY KITCHEN CONTRACTOR			HALOGEN
JB	JUNCTION BOX AT CEILING FOR FIXTURE TO BE FURNISHED BY OWNER AND INSTALLED BY CONTRACTOR			ALLOW FOR 400W IN KITCHEN; 150 W. ELSEWHERE
WL	SHOWER LIGHT	HALO	H 771 CT	50W A-19
CP	CLOSET LIGHT	HALO	H2551	50W A-19

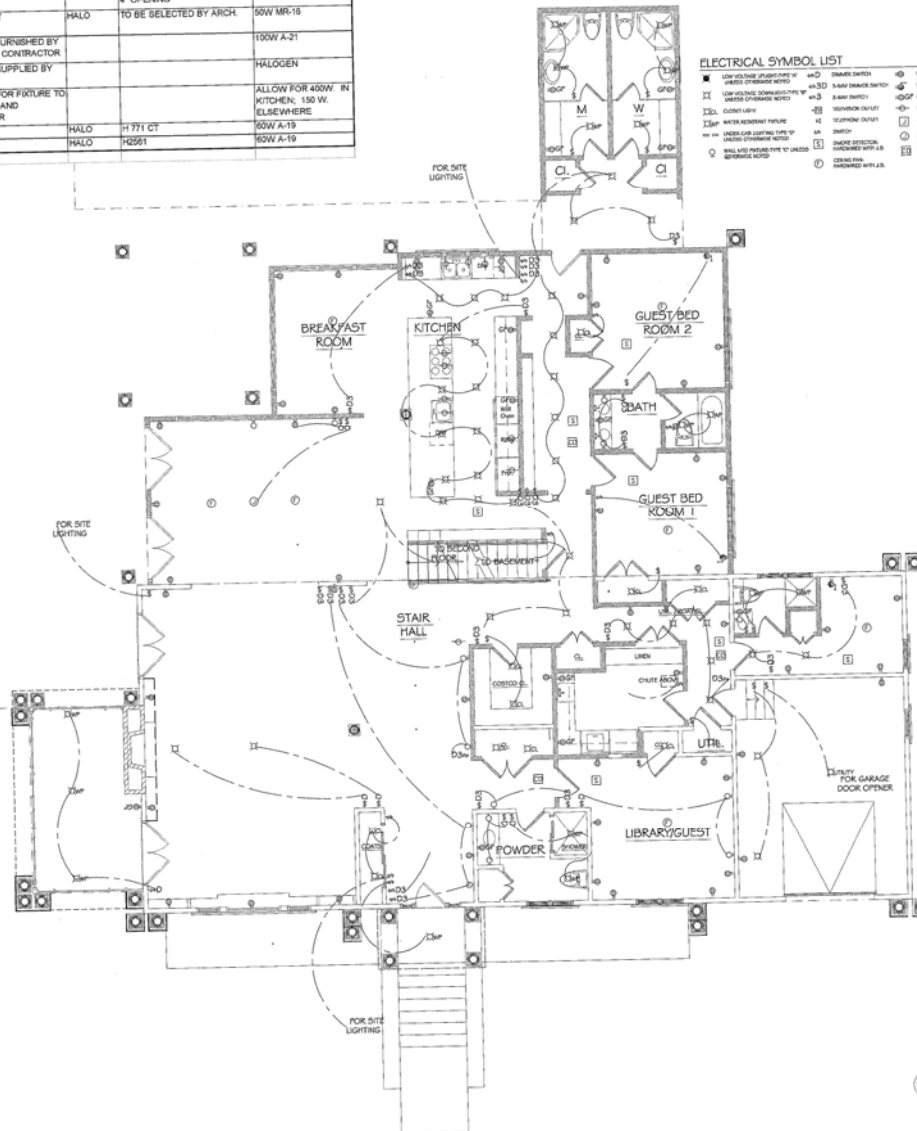

- | ELECTRICAL SYMBOL LIST | | | | | |
|-------------------------------|-----|-----------------------------------|--|--|--|
| | +0 | DIMMS SWITCH | | DUPLEX OUTLET (NOT AN UNITS NOTATION) | |
| | +3D | 3-WAY DIMMS SWITCH | | NO PLUG OUTLET | |
| | -3D | 3-WAY SWITCH | | GFCI OUTLET | |
| | +0 | TELEPHONE GROUND | | POWER FOR KITCHEN APPLIANCE (SEE INSTRUCTIONS) | |
| | +1 | TELEPHONE OUTLET | | ANTENNA BOX | |
| | 0 | SWITCH | | ANTENNA BOX FOR PRECAST PANEL TO BE FURNISHED BY OWNER | |
| | 0 | SMALL DETECTOR, MATCHED WITH S.B. | | CABINET ANTENNA (SEE INSTRUCTIONS, MATCHED WITH S.B.) | |
| | 0 | CERAMIC TILE, MATCHED WITH S.B. | | | |
| | 0 | | | | |

Renovation of the Residence of:
Mr. & Mrs. Ronald Tauber
80 Saratoga Street
Lido Beach, NY

John Davison Allen, Architect
601 West End Avenue
New York, New York 10024

tel:212.580.8975 fax:212.580.0606

No.	Date	Revision
-----	------	----------

2	8/08/02	GEN. REVISIONS-PLUG
---	---------	---------------------

Copyright © 2001
John Davison Allen, Architect

Date:	MAY 27, 2002
-------	--------------

Scale:	1/4" = 1'-0"
--------	--------------

Drawn by:	-
Checked by:	-

Title	
-------	--

ELECTRICAL
CONNECTIONS FOR PLUMBING

FIRST FLOOR PLAN

1

Step 7b

100

E-2

E-2
SCHEME G

